




WSP Canada Inc.
1 Spruce Lake Drive
Dartmouth, Nova Scotia, Canada B3B 1X7
T 902-835-9955 F 902-835-1645 www.wsp.com

SEAL:

KEY PLAN:

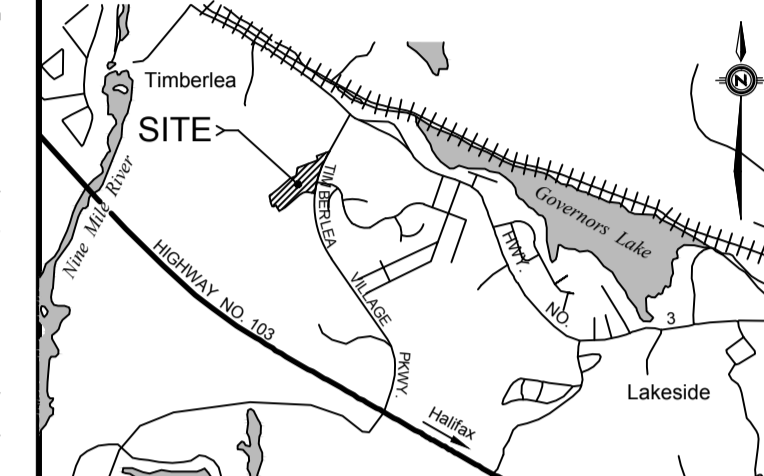

LEGEND:

UNDERGROUND PRIMARY POWER	---	---
UNDERGROUND SECONDARY POWER	---	---
UNDERGROUND COMMUNICATION	---	---
STREET LIGHT POWER	---	---
POWER URD	---	---
COMMUNICATION URD	---	---
PAD MOUNT POWER TRANSFORMER	---	---

ELECTRICAL AND COMMUNICATION CONDUIT AS-BUILTS PROVIDED BY DEXTER CONSTRUCTION. PROJECT SUPERINTENDENT PAUL HEARN.

DISCLAIMER: DRAWINGS ARE PRELIMINARY AND ARE SUBJECT TO APPROVAL PRIOR TO CONSTRUCTION. THIS DRAWING AND DESIGN IS COPYRIGHT PROTECTED WHICH SHALL NOT BE USED, REPRODUCED OR REVISED WITHOUT WRITTEN PERMISSION BY WSP CANADA INC. THE CONTRACTOR SHALL CHECK AND VERIFY ALL DIMENSIONS AND UTILITY LOCATIONS AND REPORT ALL ERRORS AND OMISSIONS PRIOR TO COMMENCING WORK. SEE SHEET 11 FOR CONSTRUCTION NOTES AND DETAILS.

REVISION:

NO.	DATE	YYYY/MM/DD	DESCRIPTION
3	2018/10/15		RECORD DRAWING
2	2018/06/20		REVISED FOR CLUBHOUSE
1	2018/03/28		REVISED FOR APPROVED LIGHT DESIGN
0	2018/01/09		ISSUED FOR REVIEW


PROJECT NO:	121-24187	DATE:	2018/01/09
ORIGINAL SCALE:	HORIZONTAL: 1:500 VERTICAL: N/A	IF THIS BAR IS NOT 25mm LONG, ADJUST YOUR PLOTTING SCALE.	
DESIGNED BY:	C. MUTCH, P.ENG., C. BOURQUE, P.ENG.		
DRAWN BY:	C. MUTCH		
CHECKED BY:	C. BOURQUE P.ENG.		
SCALE:	1:500 METRIC		

CLIENT:

BRUNELLO ESTATES INC.

CLIENT REF. #

PROJECT:

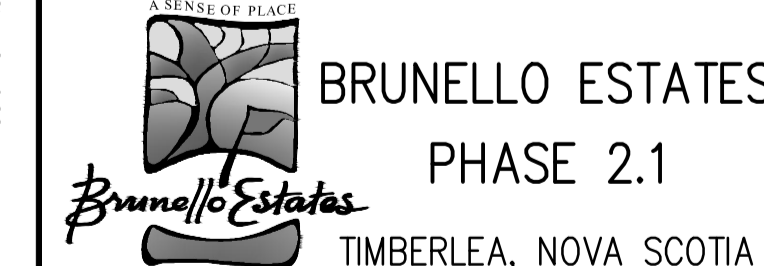

TITLE:

ELECTRICAL SITE PLAN

SHEET NUMBER:

1

SHEET #

1 OF 1


ISSUE:

RECORD DRAWING

DATE OF: 2018/10/15

REV #

3

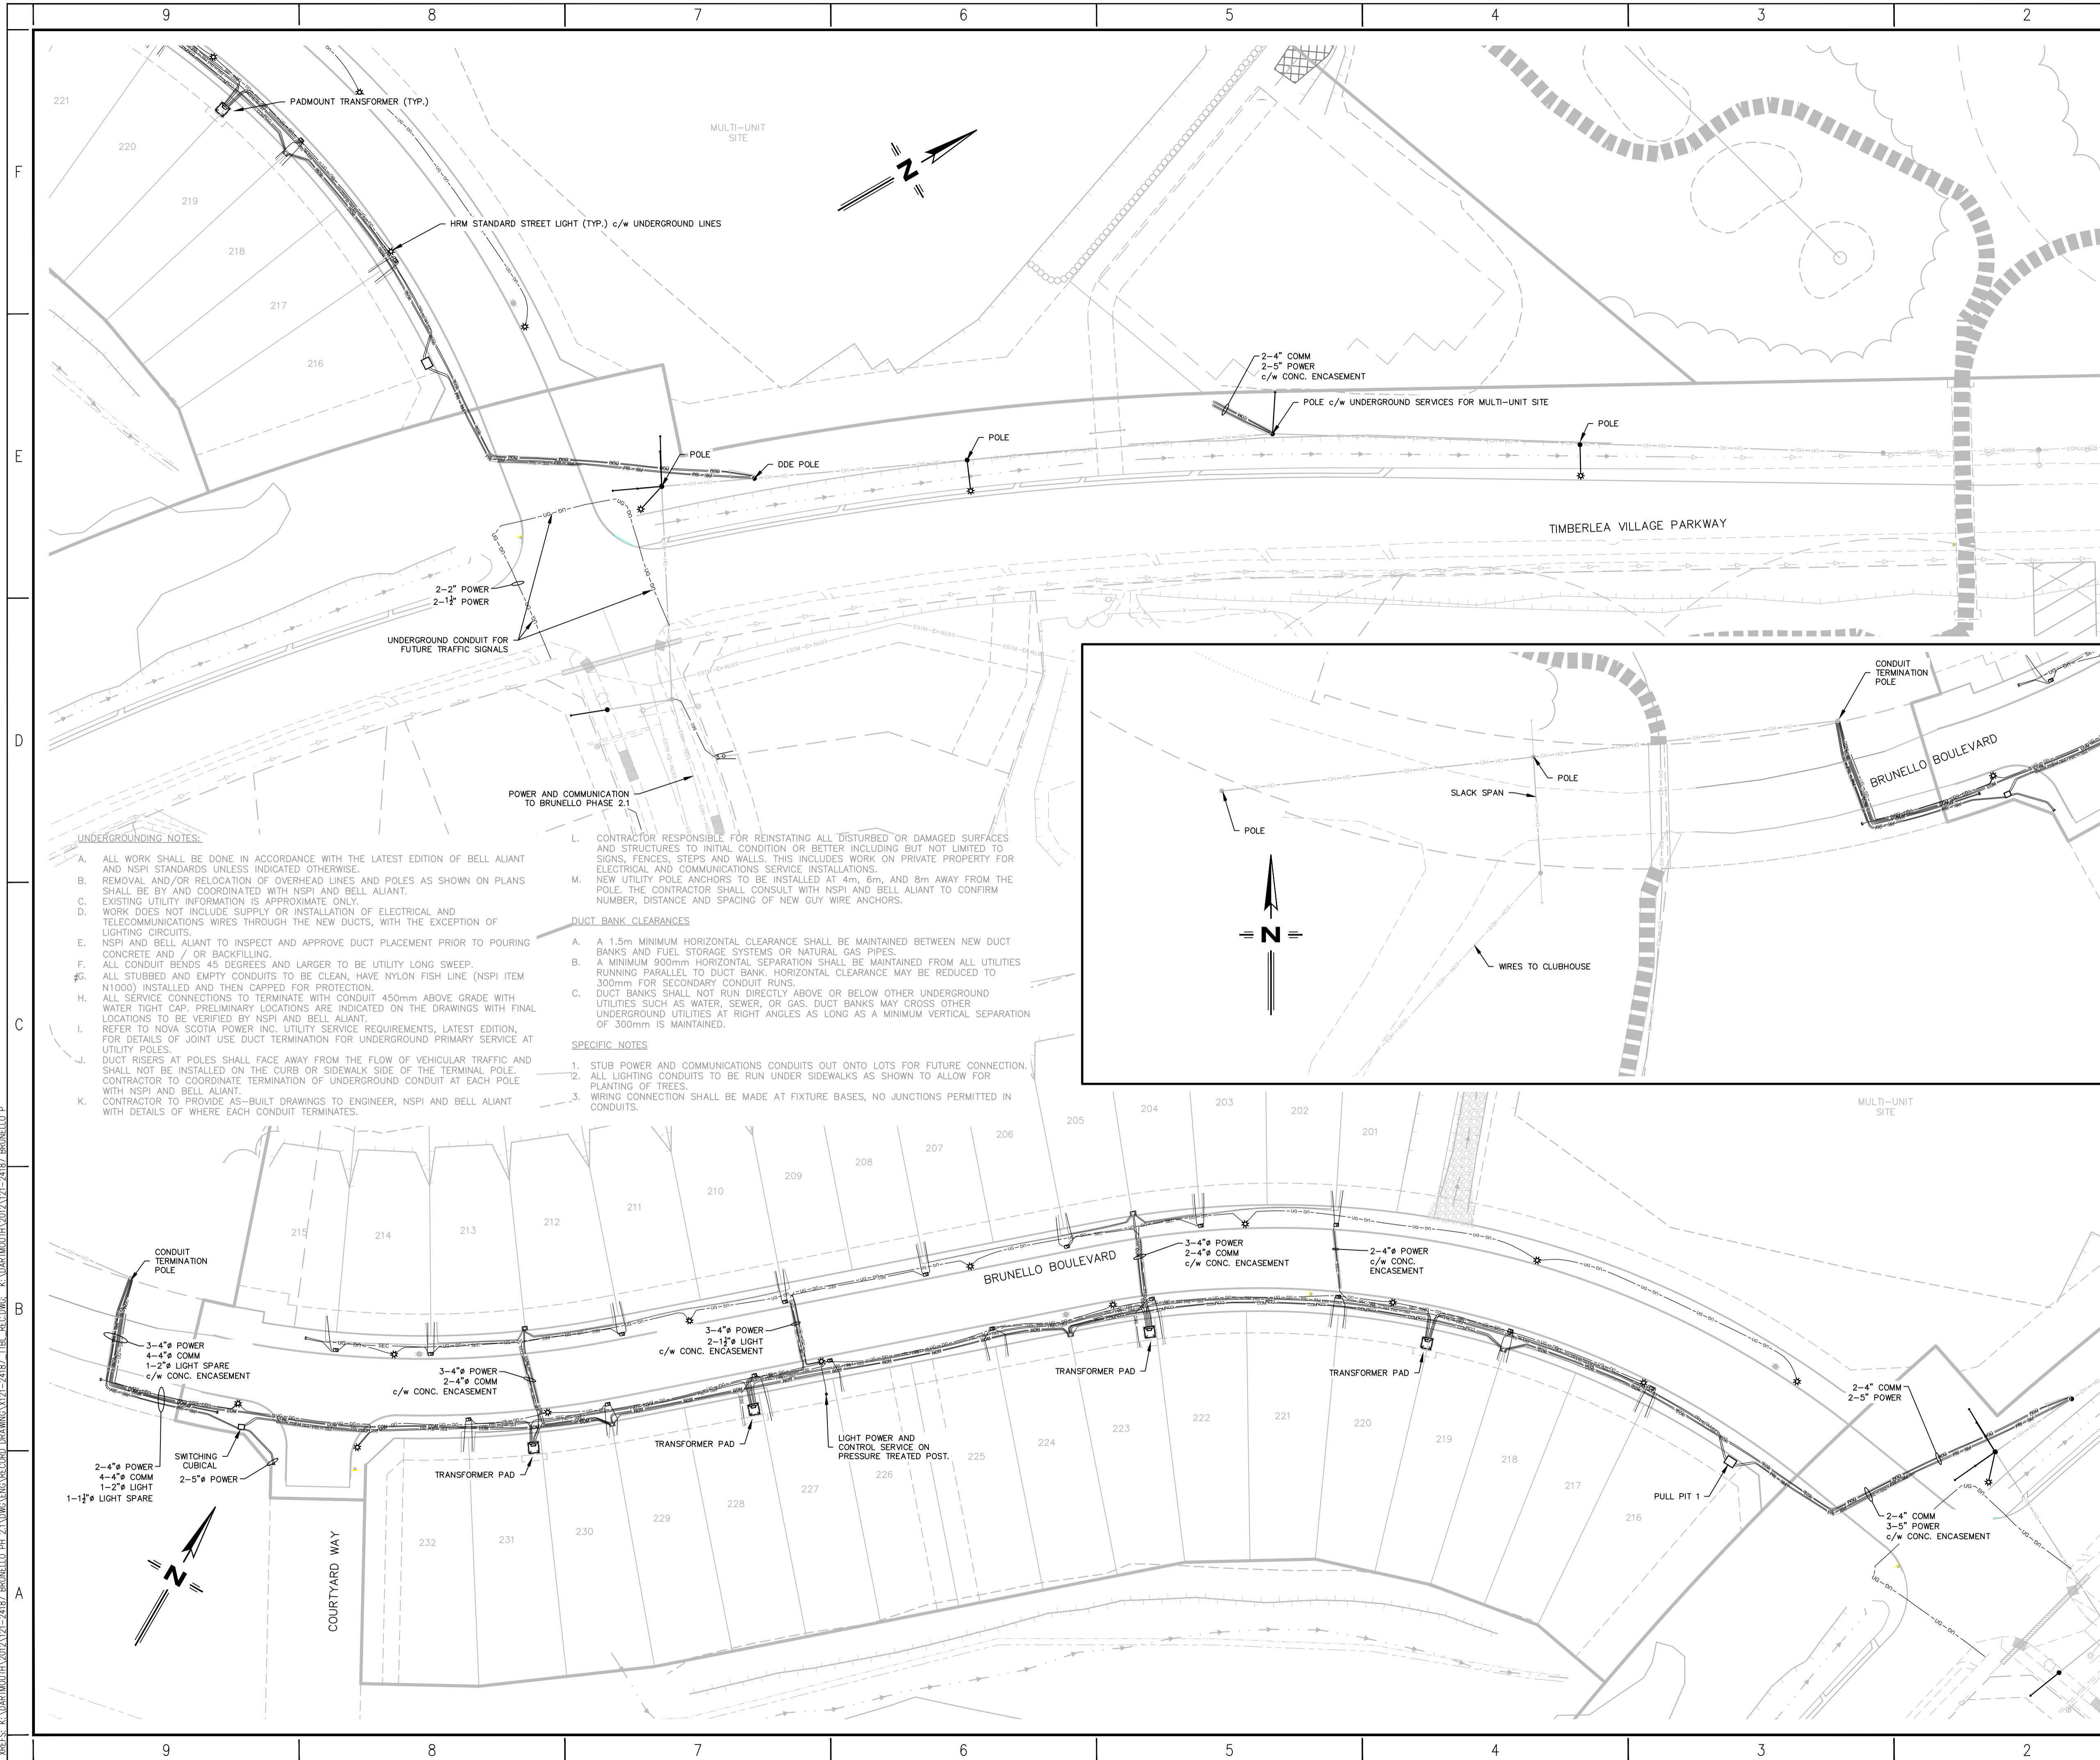

XREFS: K:\DARTMOUTH\2018\121-24187-BRUNELLO.PH.2\DWG\ENG\RECORD DRAWING\121-24187-BRUNELLO.PH.2.DWG (ENG) RECORD DRAWING POWER PLAN.DWG 001 PRINTED: 9:13 AM 2018/10/15 BY: CRAIG LUTZ